


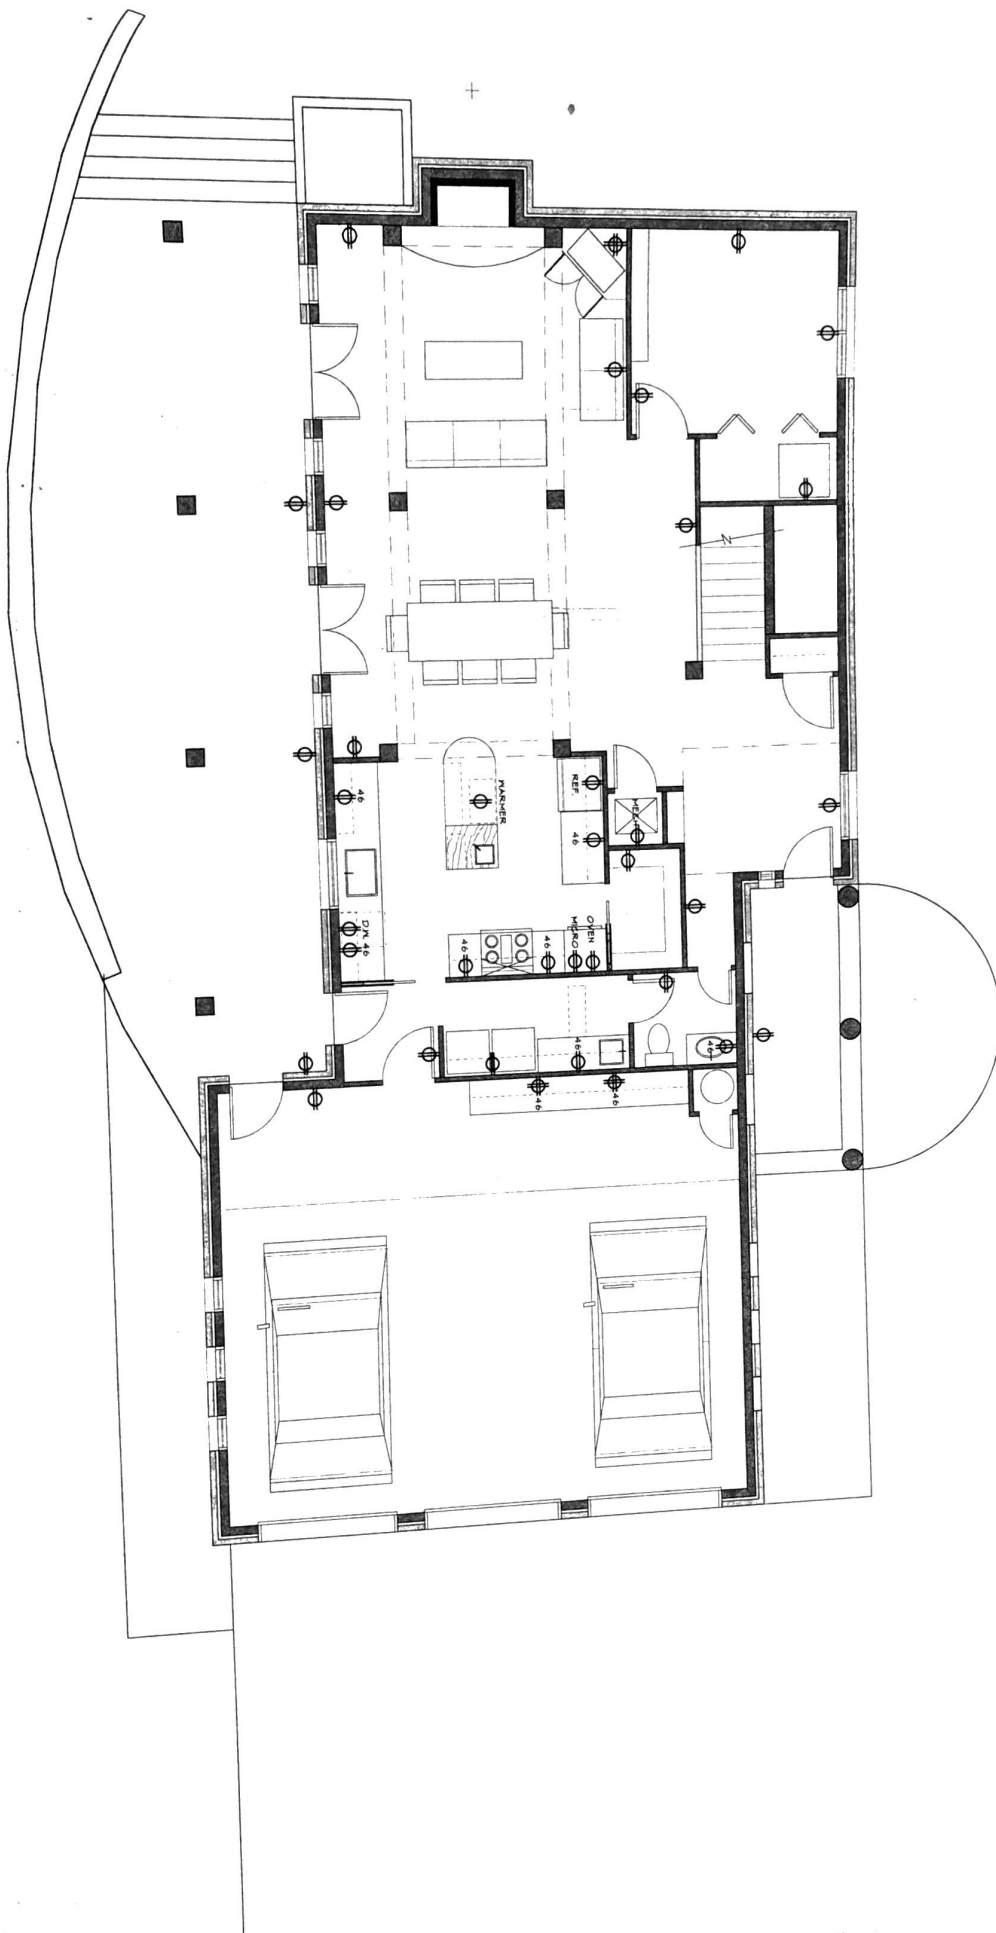


FIRST FLOOR POWER PLAN

SCALE: 1/4" = 1'-0"

ARTIST RESIDENCE

FAZIO ARCHITECTS
 9602 Bliternut Cove
 1759 (512) 345-3263

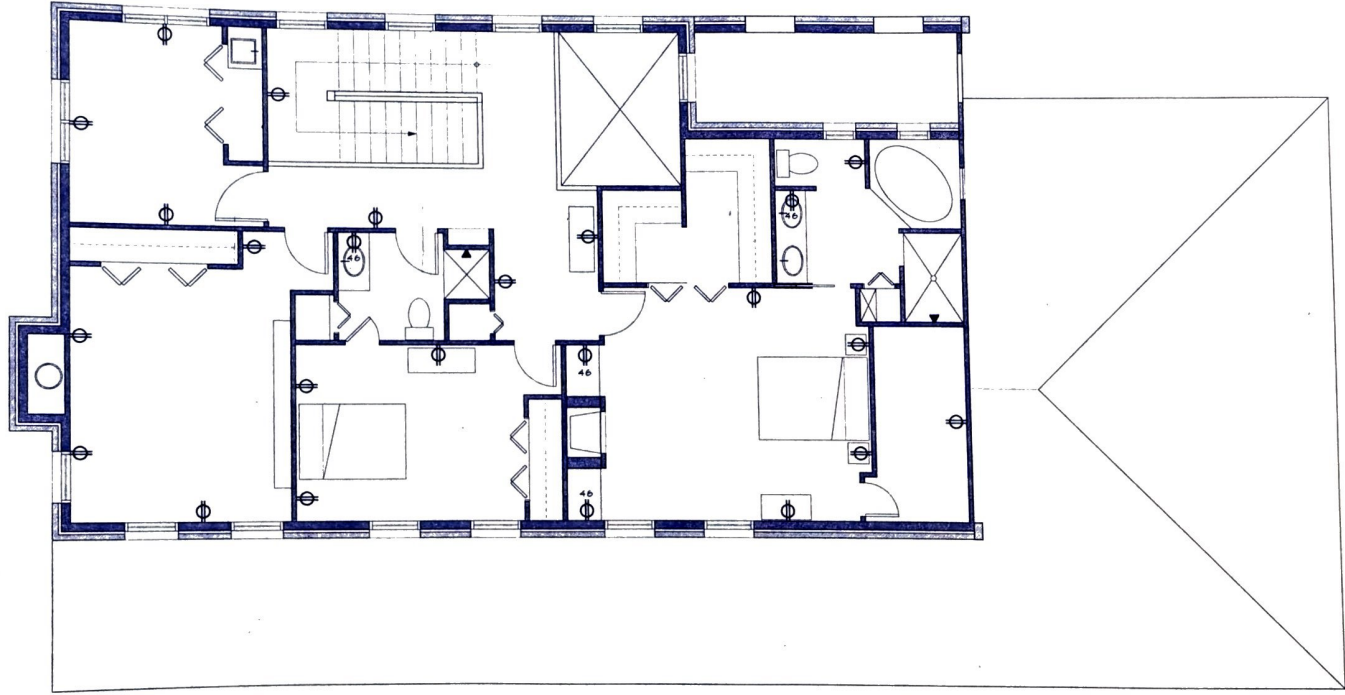

SECOND FLOOR POWER PLAN